

RESOLUTION APPROVING THE DETAILED CONSTRUCTION PLANS FOR PTI FOR PADANARUM ROAD WATERLINE IMPROVEMENT PROJECT, GENEVA TOWNSHIP, ACDES

WHEREAS, Doug Starkey, Director of the Ashtabula County Department of Environmental Services, has presented detailed construction plans prepared by Verdantas, and approved by Ashtabula County Sanitary Engineer, for the Padanarum Road Waterline Improvement Project, Geneva Township; and

WHEREAS, the project description is as follows:

This is a waterline project where the existing water main will be extended approximately 1280 LF of 8" c-909 on Padanarum Rd from parcel 17-007-00-043-00 to 17-008-00-007-00 in Geneva Township, Ashtabula County.

WHEREAS, Doug Starkey, Director of ACDES, is authorized after plan approval to submit signed drawings for Permit to Install (PTI); and

WHEREAS, Doug Starkey, Director of ACDES, recommends approval of these plans; now

THEREFORE, BE IT RESOLVED, by the Board of County Commissioners of the County of Ashtabula, Ohio, that:

Section 1. The detailed construction plans for the Padanarum Rd. Waterline Improvement Project in Geneva Township are hereby approved.

Section 2. Those detailed plans shall be filed in the office of the Ashtabula County Sanitary Engineer, in the Department of Environmental Services and kept continuously on file there for inspection by all persons interested therein.

Section 3. This Board finds and determines that all formal actions of this Board concerning and relating to the adoption of this resolution were taken in an open meeting of the Board and all deliberations of this Board and of any of its committees that resulted in those formal actions were in meetings open to the public.

**ASHTABULA COUNTY COMMISSIONERS
CERTIFICATION PAGE**

Resolution No. 2025-371

August 28, 2025

**RESOLUTION APPROVING THE DETAILED CONSTRUCTION PLANS FOR PTI
FOR PADANARUM ROAD WATERLINE IMPROVEMENT PROJECT, GENEVA
TOWNSHIP, ACDES**

Upon the motion of Kathryn L. Whittington, seconded by Casey R. Kozlowski.

VOTE:

J.P. Ducro IV	Aye
Casey R. Kozlowski	Aye
Kathryn L. Whittington	Aye

CERTIFICATE OF CLERK

IT IS HEREBY CERTIFIED that the foregoing is a true and correct transcript of a resolution acted upon and duly passed by the Board of County Commissioners of Ashtabula County, Ohio, on the date noted above.

Crystal Sturgill
Crystal Sturgill, Clerk of the Board
Board of County Commissioners
Ashtabula County, Ohio

1/Altng

PADANARUM ROAD WATERLINE IMPROVEMENT PLANS

GENEVA TWP., ASHTABULA COUNTY, OHIO

MAY, 2025

INDEX OF SHEETS

TITLE SHEET-OVERALL PLAN AND GENERAL NOTES.....	1
PLAN AND PROFILE, DETAILS.....	2-3
WATERLINE NOTES AND DETAILS.....	4

APPROVALS

ASHTABULA COUNTY DEPARTMENT OF ENVIRONMENTAL SERVICES

APPROVED THIS _____ DAY OF _____, 2025

DIRECTOR, ACDES _____ DOUG STARKEY

ASHTABULA COUNTY COMMISSIONERS

APPROVED THIS _____ DAY OF _____, 2025

KATHRYN L. WHITTINGTON PRESIDENT

CASEY R. KOZLOWSKI VICE PRESIDENT

J. P. DUCRO, IV COMMISSIONER

SANITARY ENGINEER _____ GEORGIA CONWAY

UTILITIES

THE LOCATION OF ALL UNDERGROUND UTILITY FACILITIES ARE SHOWN ON THE PLANS FROM DATA AVAILABLE AT THE TIME OF THE FIELD SURVEY IN ACCORDANCE WITH SECTION 153.64 OF THE OHIO REVISED CODE. THE CONTRACTOR SHALL BE RESPONSIBLE FOR NOTIFICATION OF THE EXISTING UTILITY OWNERS AND UTILITY PROTECTION SERVICE LISTED BELOW IN ACCORDANCE WITH SECTION 154.64 OF THE O.R.C. AND AS OUTLINED IN PROJECT SPECIFICATIONS.

THE UTILITY OWNERSHIPS ARE AS FOLLOWS:

OHIO UTILITIES PROTECTION SERVICE
106 WEST RYEN, ROOM 427
YOUNGSTOWN, OHIO 44051
PH: (800) 362-2764

TIME WARNER CABLE
ENGINEERS' OFFICE
14300 S. INDUSTRIAL PARKWAY
MAPLE HEIGHTS, OHIO 44137
PH: 216-663-4003

DOMINION OHIO GAS COMPANY
7001 CENTER ROAD
ASHTABULA, OHIO 44004
PH: 992-5100


THE CLEVELAND ELECTRIC
ILLUMINATING COMPANY
2210 SOUTH RIDGE ROAD WEST
ASHTABULA, OHIO 44004
PH: (440) 994-8267
ATTN. - GARY WEIR

THE CITY OF GENEVA SEWERAGE TREATMENT PLANT
141 NORTH AVENUE
GENEVA, OHIO 44041
PH: 1-440-466-4228

THE CITY OF GENEVA
44 NORTH FOREST ST.
GENEVA, OHIO 44041
PH: 1-440-466-4675

GENEVA TOWNSHIP
4858 CORK-COLD SPRINGS RD.
GENEVA, OHIO 44041
PH: 1-440-466-2242

ASHTABULA COUNTY ENVIRONMENTAL DEPT.
25 W. JEFFERSON ST.
JEFFERSON, OHIO
PH: 1-440-576-3722

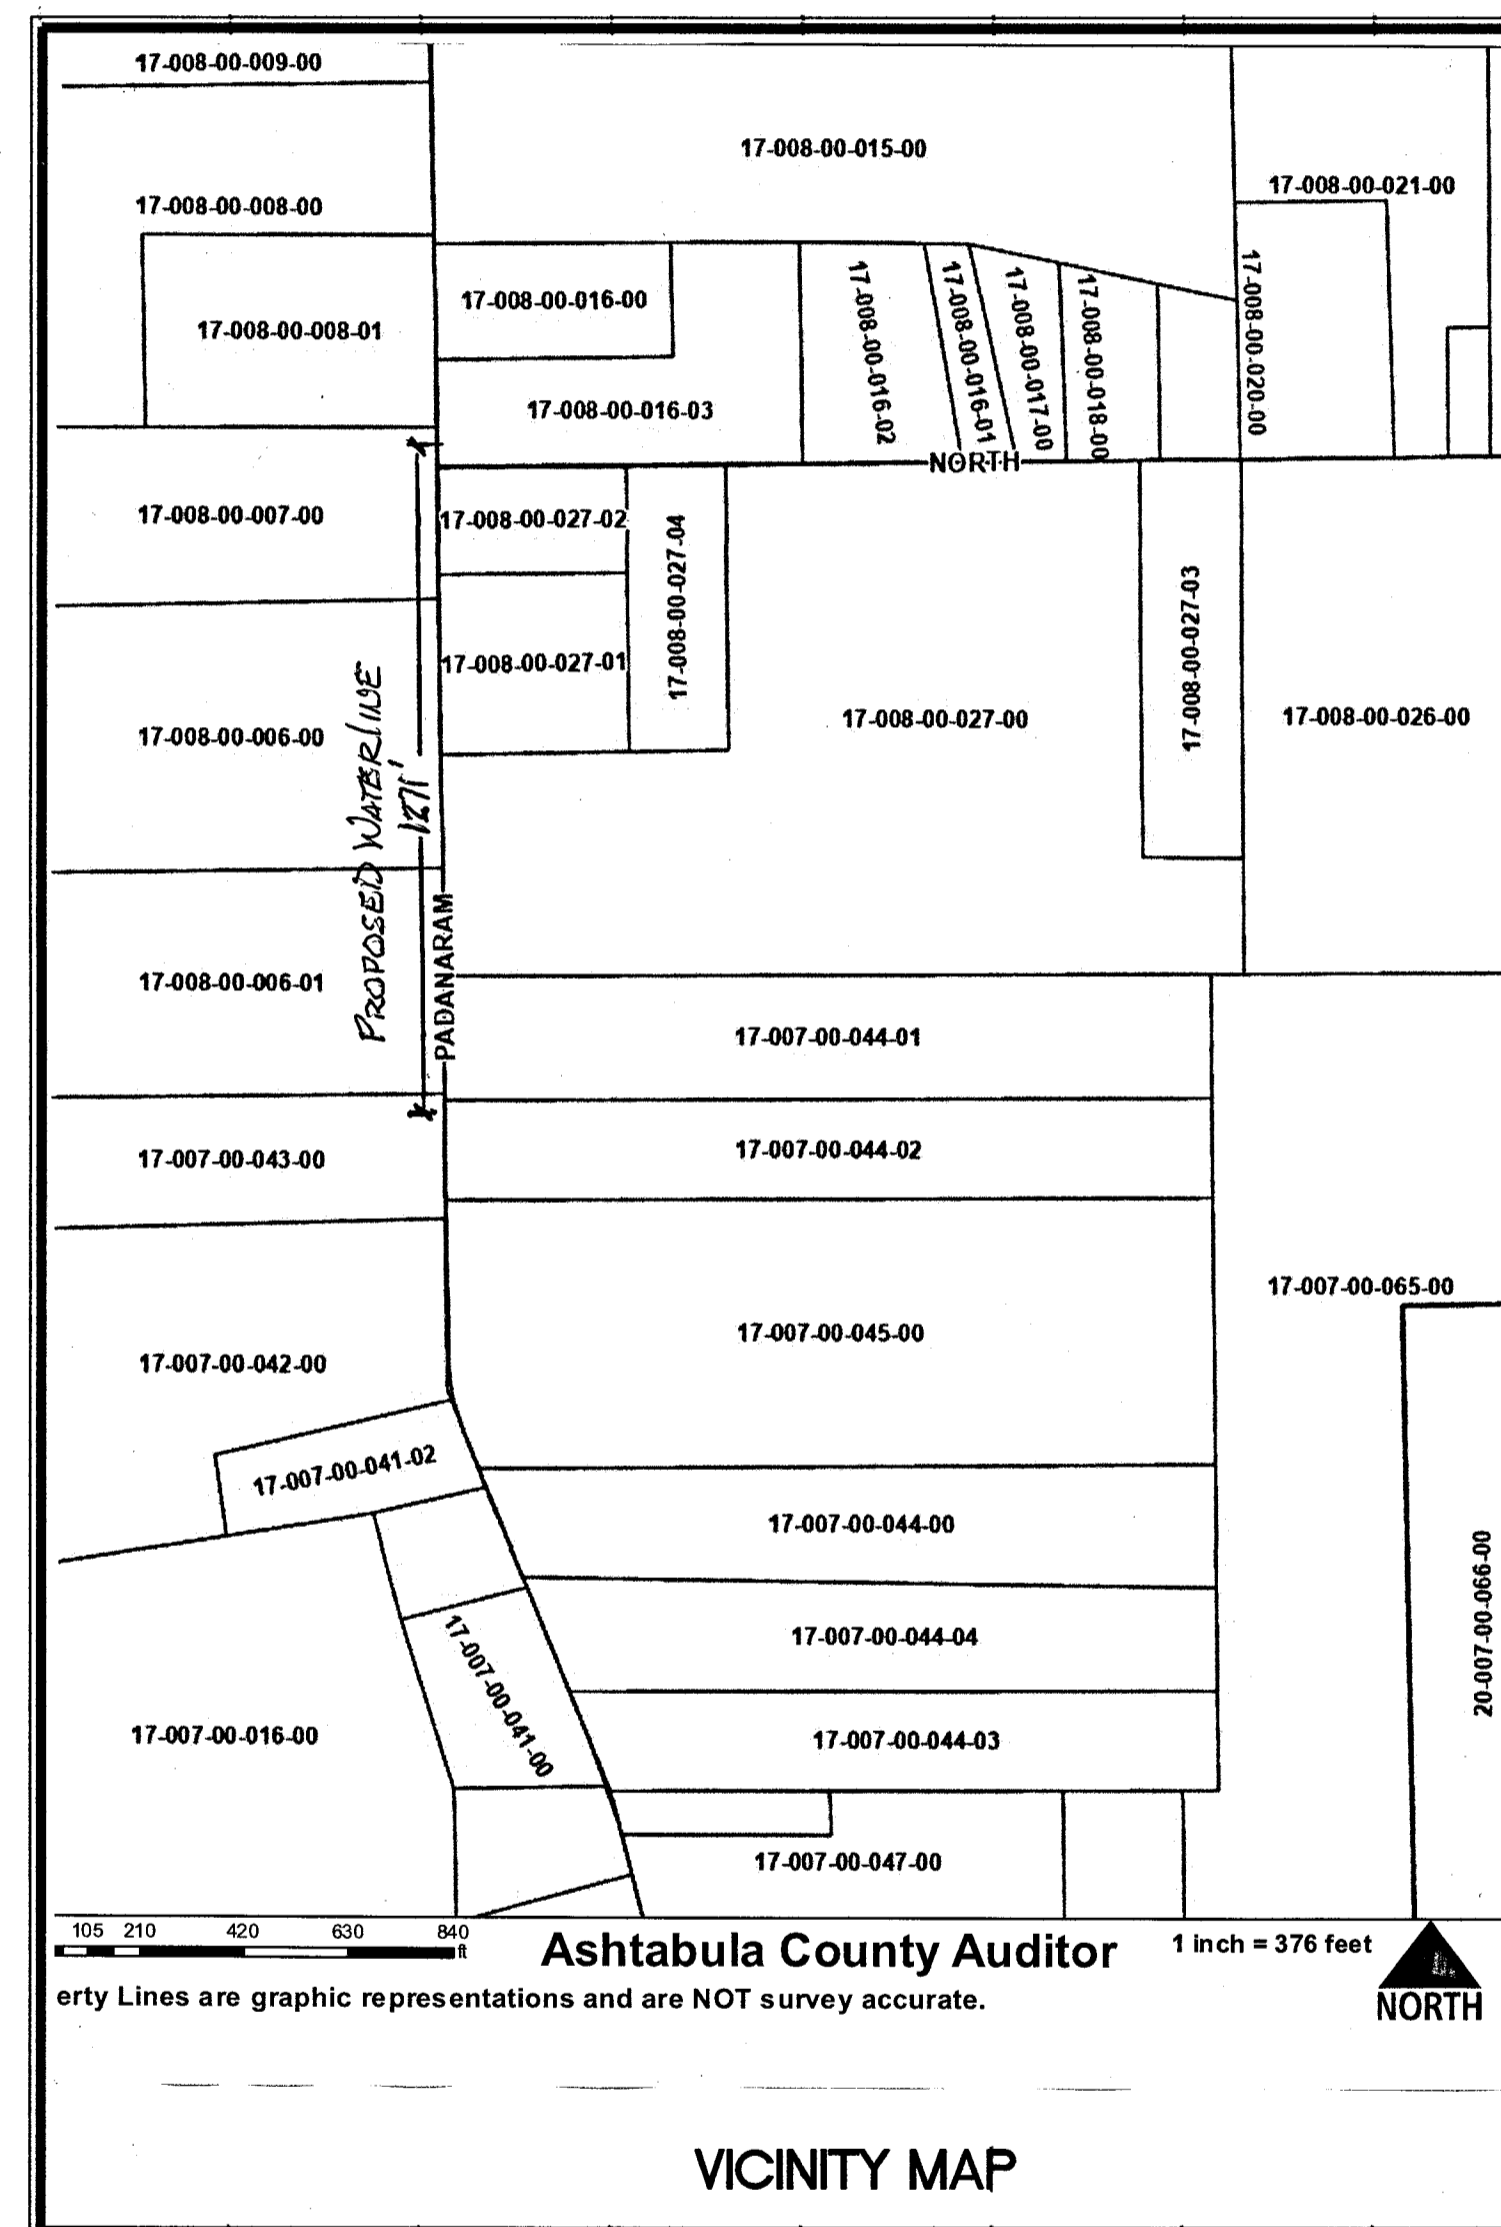

NOTES:


- TEN FOOT MIN. HORIZONTAL SEPERATION (OUT TO OUT) MUST BE MAINTAINED BETWEEN THE WATERLINE AND SANITARY AND STORM SEWERS AT ALL CROSSINGS.
- AN 18" VERTICAL SEPERATION (OUT TO OUT) MUST BE MAINTAINED BETWEEN THE WATERLINE AND SANITARY AND STORM SEWERS AT ALL CROSSINGS.
- BOOSTER PUMPS ARE PROHIBITED ON SERVICE CONNECTIONS.
- THE WATERLINE SHALL PROVIDE A MINIMUM OF 35 PSI PRESSURE AT THE CURB STOP DURING NORMAL OPERATIONS.
- WATERLINES SHALL BE INSTALLED AND PRESSURE TESTED ACCORDING TO AWWA C-605.
- WATERLINES SHALL BE DISINFECTED ACCORDING TO AWWA C-651.
- A MINIMUM OF 35 PSI SHALL BE MAINTAINED TO THE CURB STOP DURING NORMAL OPERATING CONDITIONS.
- A MINIMUM PRESSURE OF 20 PSI SHALL BE MAINTAINED AT GROUND LEVEL AT ALL POINTS IN THE DISTRIBUTION SYSTEM UNDER ALL CONDITIONS OF FLOW.

DAVID RAPP SERVICES

Engineer - Surveyor - Inspector

dave@usaec.com 440-983-1607

OHIO UTILITIES PROTECTION SERVICE
2 WORKING DAYS
BEFORE YOU DIG
CALL TOLL FREE 800-362-2764

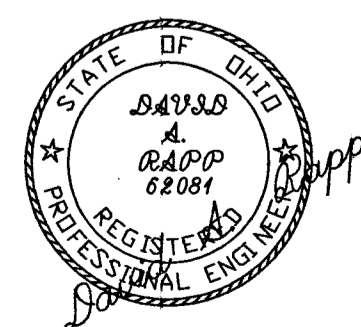


David A. Rapp 05/25/25
DAVID A. RAPP P.S. No. 62081


BEND RT.
 C/L STA: 6+60, 221
 W/L STA: 0+330
 C/L STA: 6+50, 12.5L
 W/L STA: 0+20
 12" x 8" REDUCER
 C/L STA: 6+35, 12.5L
 W/L STA: 0+05
 EXIST. 12" WATERLINE VALVE
 C/L STA: 6+30, 12.3 L
 EXIST. 12" HD. TEE
 C/L STA: 0+26.64, 20R
 W/L STA: -0+05

CECILIA QUIST
 PP# 17-008-00-006-00
 VOL. 737, PAGE 872

ALLISON AND JOEL LOYD
 PP# 17-008-00-006-00
 VOL. 737, PAGE 872

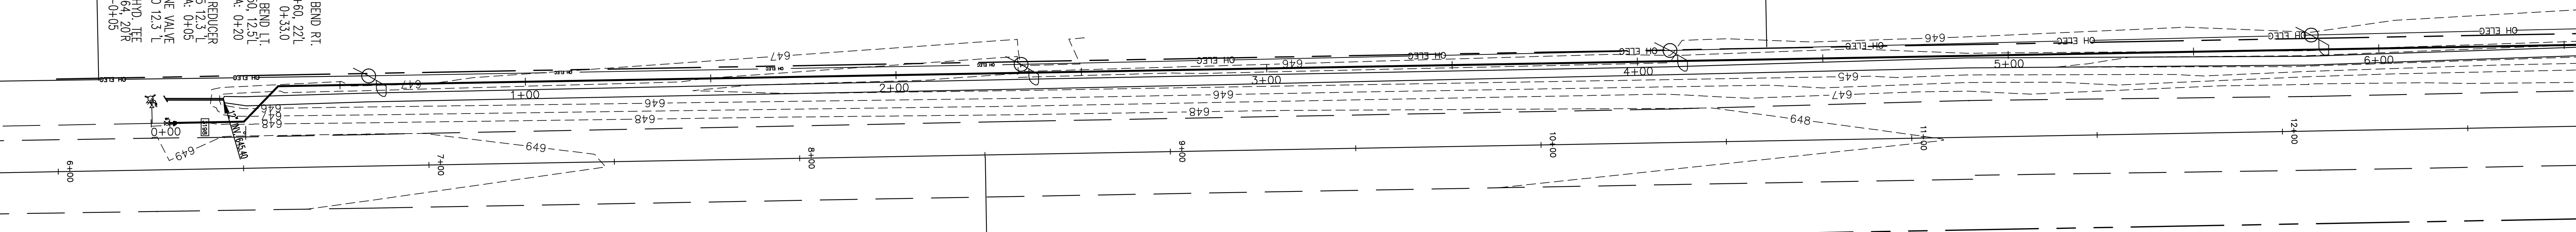

PADANARUM ROAD (Road Alignment No. 211, Section A) 50' WIDE

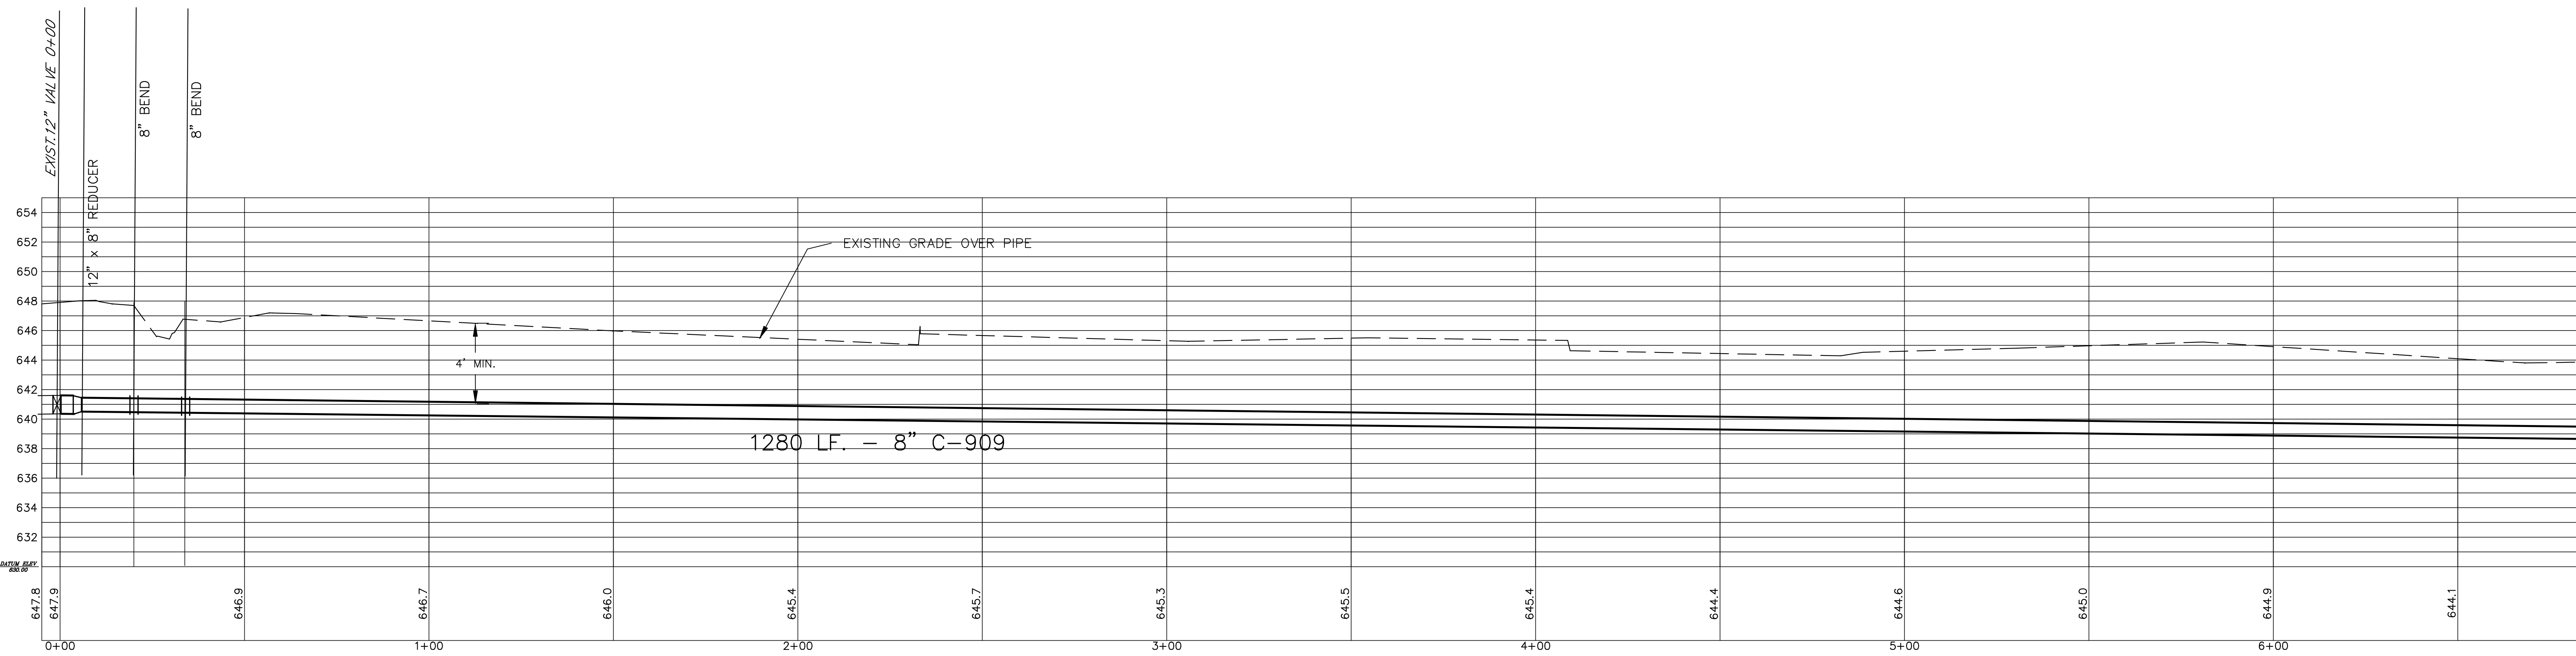


DAVID RAPP SERVICES
 dave@usaeq.com 440-983-1607

DATE: **MAY, 2025**
 DRAWN BY: **DAR**
 CHECKED BY:
 APPROVED BY: **DAR**
 PE No. **62081**

PADANARUM ROAD WATERLINE IMPROVEMENT PLANS
 GENEVA TOWNSHIP - ASHTABULA COUNTY, OHIO

PLAN AND PROFILE

Hor. Scale 1" = 20'	Vert. Scale 1" = 5'
CONTRACT No. 45101	
SHEET No. 2	OF 4

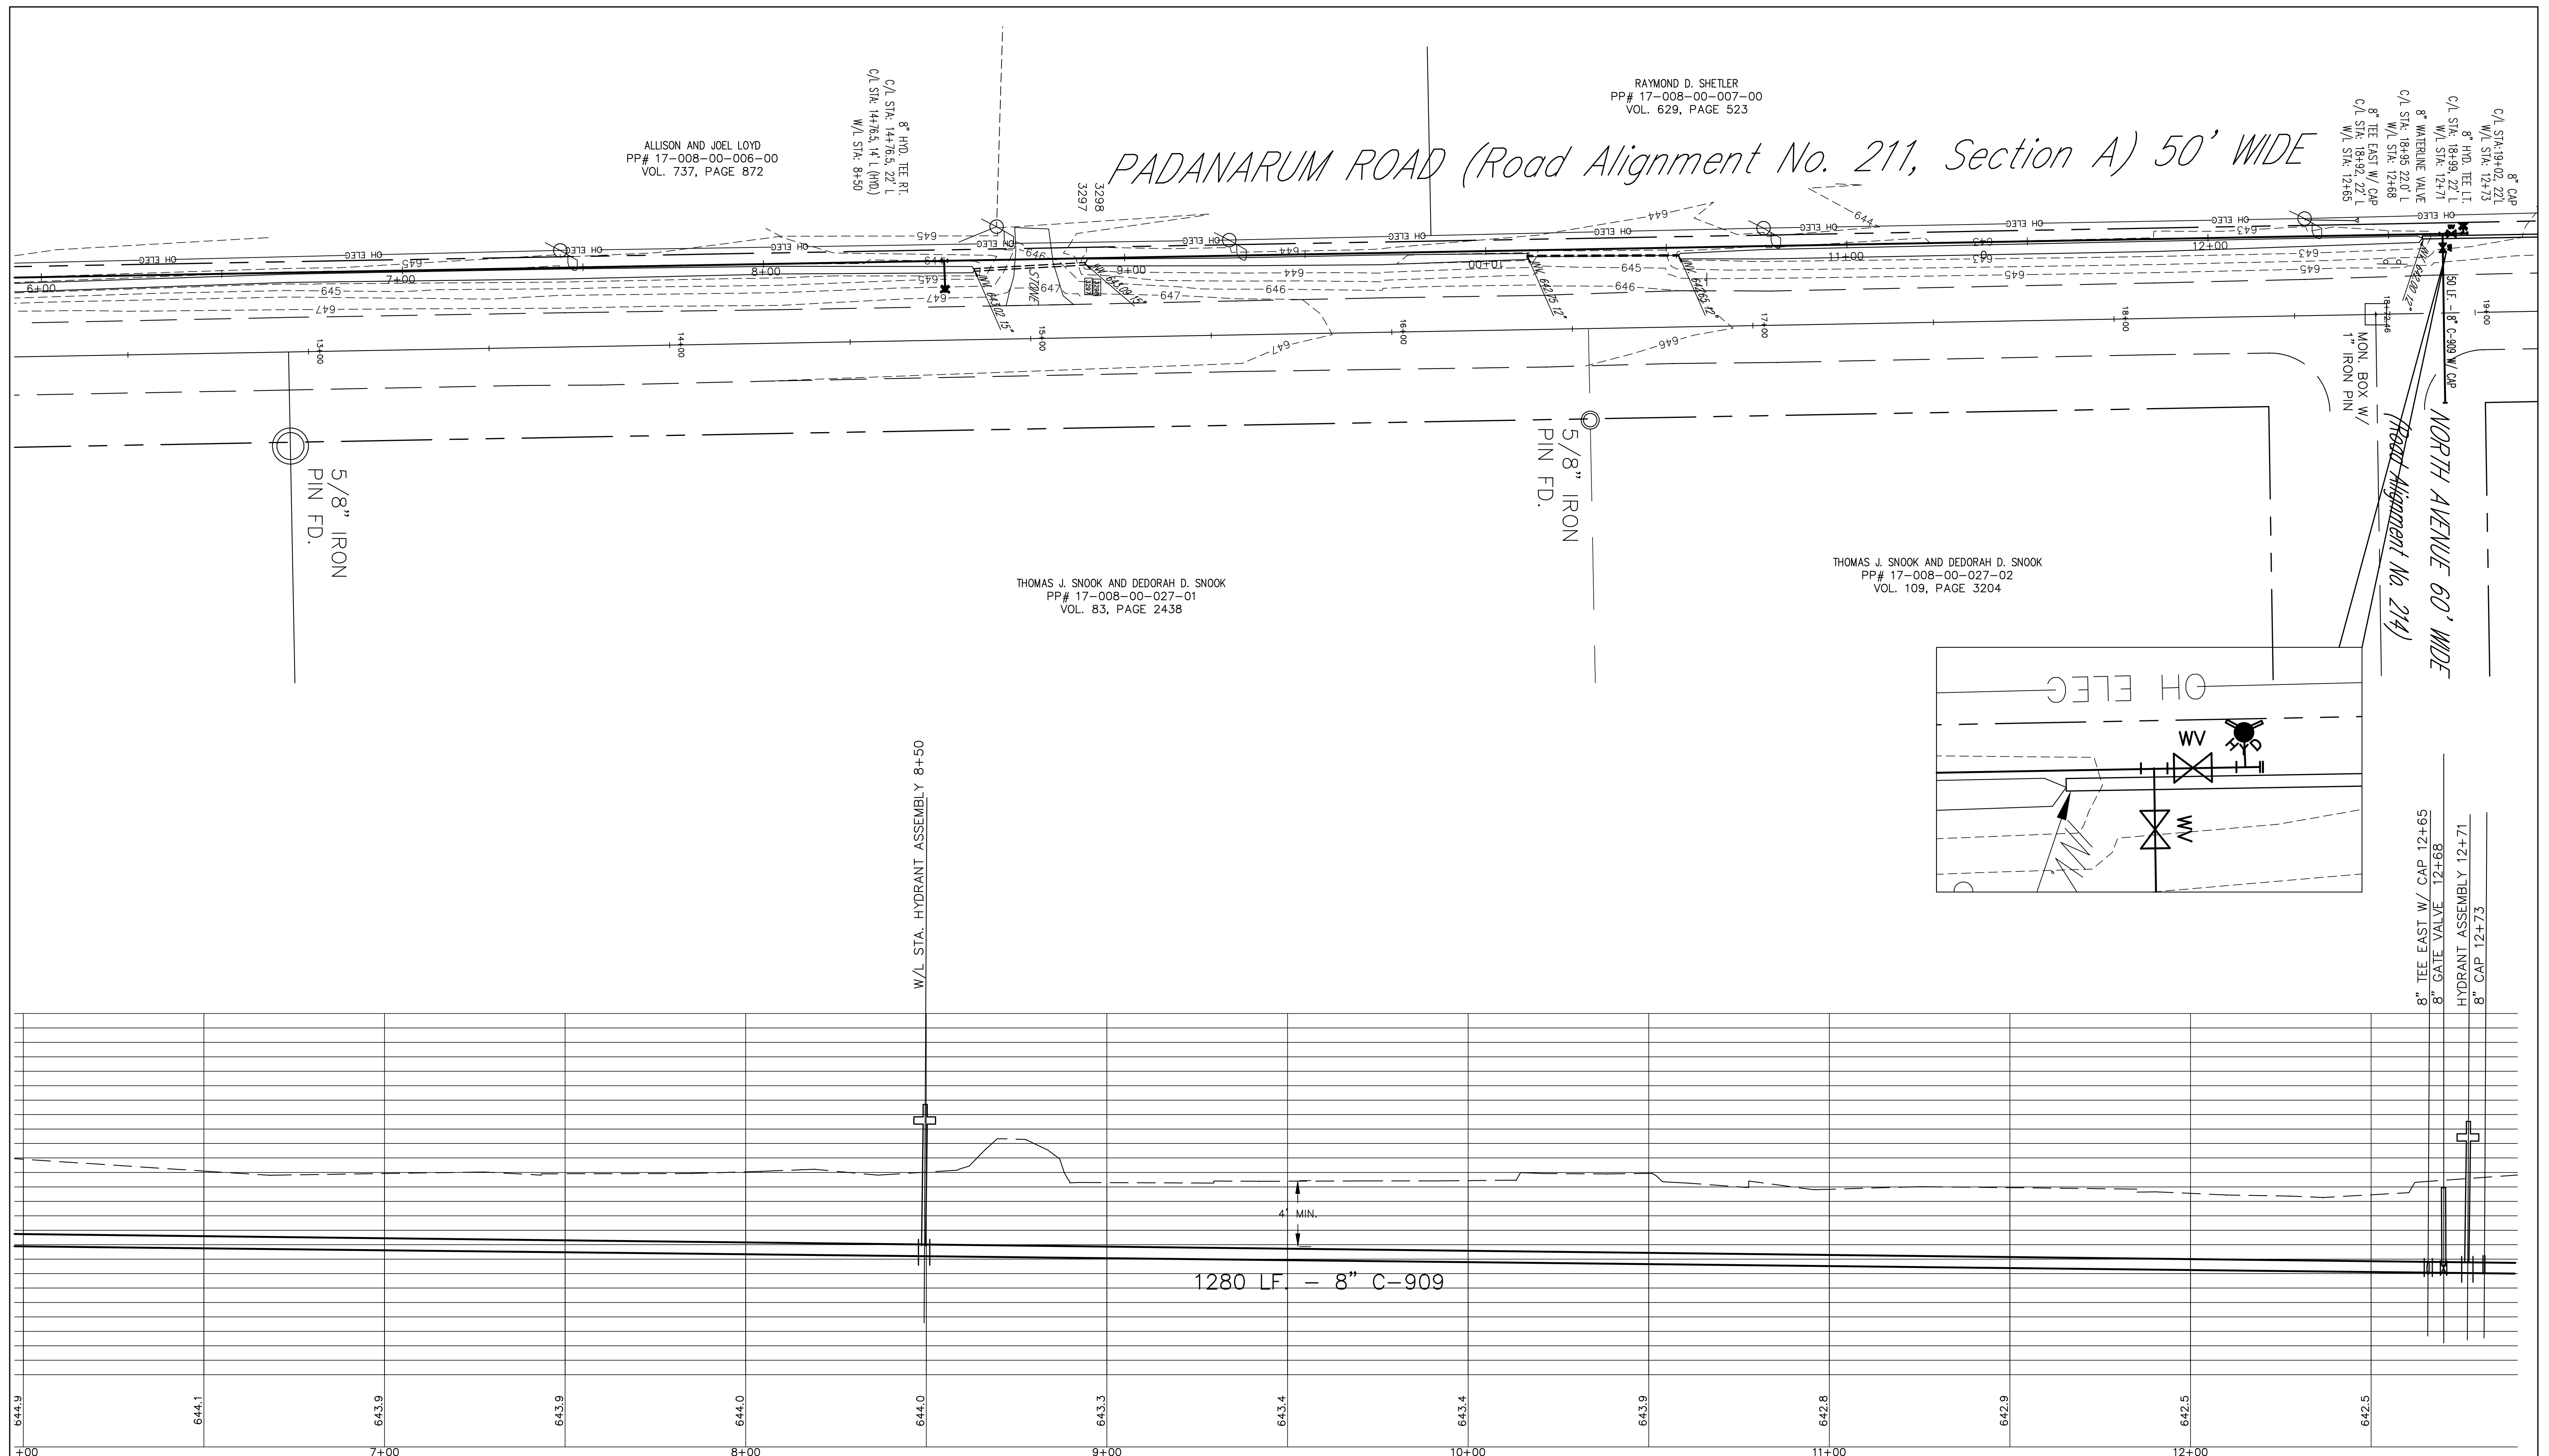

DAVID RAPP SERVICES

dave@usaeg.com 440-983-1607

DATE: MAY, 2025
 DRAWN BY: DAR
 CHECKED BY:
 APPROVED BY: DAR
 PE No. 62081

PADANARUM ROAD WATERLINE IMPROVEMENT PLANS
 GENEVA TOWNSHIP - ASHTABULA COUNTY, OHIO

PLAN AND PROFILE

Hor. Scale **1" = 20'** Vert. Scale **1" = 5'**
 CONTRACT No. **45101**
 SHEET No. **3** OF **4**

